


LEGEND	
SYMBOLS	DESCRIPTION
+ 205.7	DEMOSIS EXISTING ELEVATION LEVEL
SOPM	DEMOSIS SURVEY SET OUT POINTS
[Symbol]	EXISTING BUILDINGS


SETTINGS OUT POINTS	
SOP1	X=4845.11 Y=2152.37
SOP2	X=4886.11 Y=2182.37
SOP3	X=4857.11 Y=2167.37
SOP4	X=4872.10 Y=2132.37



DATE	NO	REVISION
MAY 2020	1	ISSUED FOR PLANNING
APR 2020	0-01	ISSUED FOR INFORMATION
PROJECT: PROSPECT TELECOMMUNICATION TOWER REPLACEMENT		
TITLE: TOWER FOUNDATION LOCATION AND SET OUT		
SCALE	AS SHOWN	JOB NO. 18403
DRAWN BY	ICC	DRAWINGS #
DATE	MARCH 2020	SP1.0
DRAWING SCALE SHOWN IS FOR FULL SIZE DIMENSIONS ARE IN METERS UNLESS OTHERWISE STATED SHEETS ARE IN METRIC SCALE SHOWN IN METERS 24"x36" SHEET = 18" x 24" ON 11"x17" SHEET		

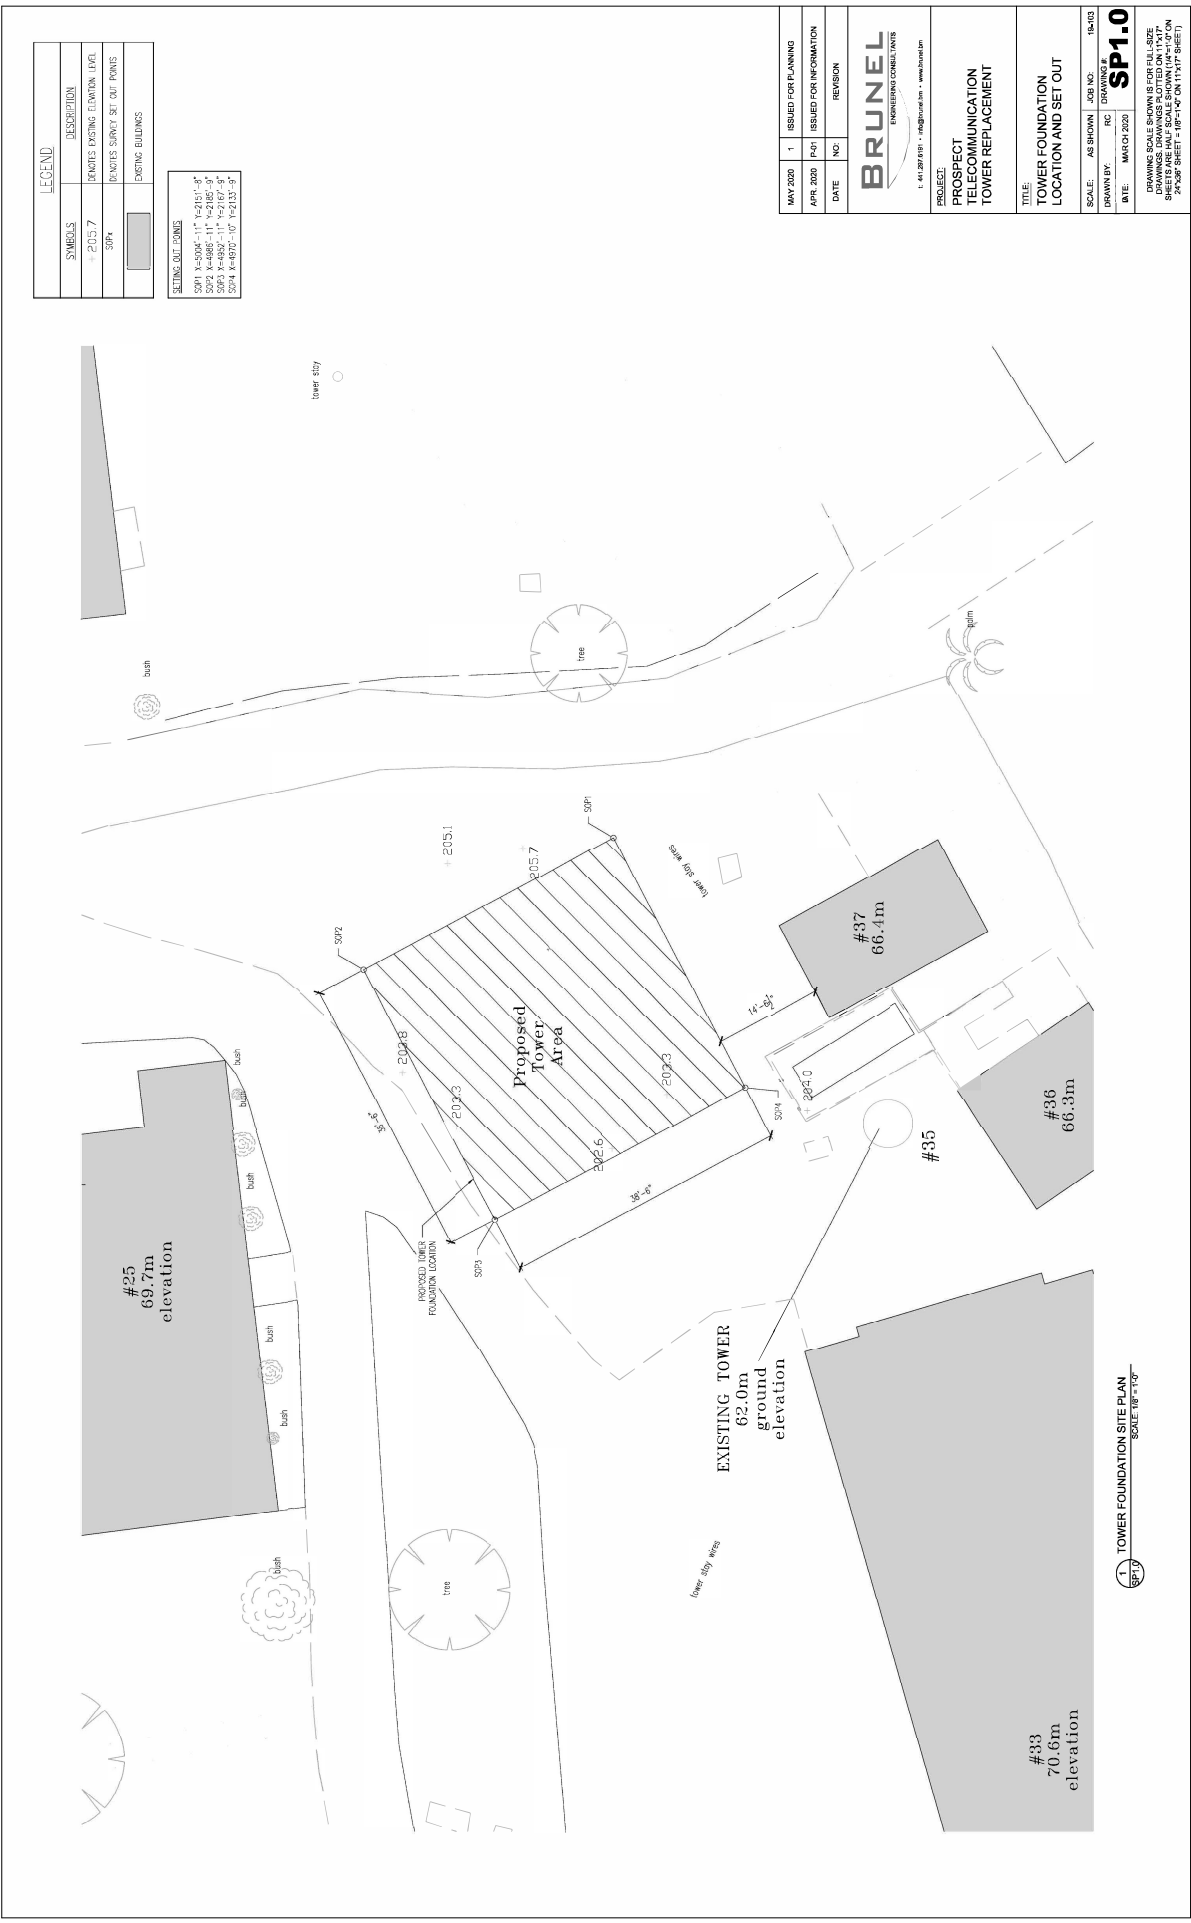

1 TOWER FOUNDATION SITE PLAN
SCALE 1/8" = 1'-0"

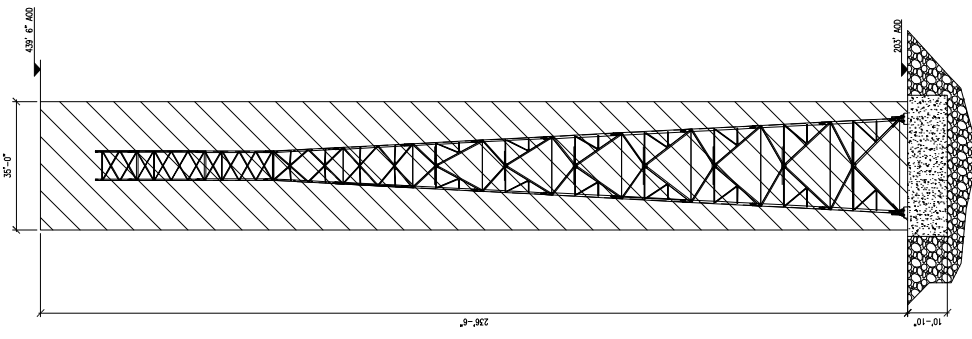

2. TOWER ELEVATION AND ENVELOPE
SCALE: 1/16" = 1'-0"



1. TOWER FOOTPRINT
SCALE: 1/16" = 1'-0"




MAY 2020	1	ISSUED FOR PLANNING
DATE	NO.	REVISION
BRUNEL ENGINEERING CONSULTANTS		
PROJECT: PROSPECT TELECOMMUNICATION TOWER REPLACEMENT		
TITLE: GENERAL ARRANGEMENT		
SCALE:	AS SHOWN	JOB NO.: 10423
DRAWN BY:	MC	DRAWING #: SP1.1
DATE:	MARCH 2020	
DRAWING SCALE SHOWN IS FOR FULL-SCALE SHEETS AND FULL-SCALE SHOWN DIMENSION SHEET. SHEET = 18" x 24" ON 11x17" SHEET.		

LEGEND	
SYMBOLS	DESCRIPTION
(Symbol)	6" HIGH DENSITY POLYETHYLENE (HDPE) WATER MAIN DIVERSION PIPE
(Symbol)	6" HDPE WATER MAIN TO BE ABANDONED
(Symbol)	LEGACY MAINS TO BE ABANDONED
(Symbol)	4" PVC WELL WATER PIPES NOT LOCATED IN SITE DURING INVESTIGATIONS TO BE ABANDONED
(Symbol)	ADDITIONAL WELL WATER PIPES

- NOTES** - SERVICES IDENTIFIED ARE LOCATED AS ACCURATELY AS POSSIBLE WHERE THEY HAVE BEEN PHYSICALLY ENCOUNTERED. SERVICES IDENTIFIED BY THIRD PARTIES ARE LOCATED AS INFORMED BY THE DIVISION AND ABANDONMENT OF SERVICES AS AGREED WITH SERVICE PROVIDERS.
- SERVICE PROVIDERS ARE KNOWN TO PASS THROUGH THE AREA N.E. OF ADJACENT TO THE SITE. THESE SHALL BE SHUT OFF AND ABANDONED AS AGREED WITH THE MINISTRY OF PUBLIC WORKS WATER SECTION.
 - FIRE HYDRANT OUTSIDE OF THE WORKS AREA TO BE ABANDONED.



MAY 2020	1	ISSUED FOR PLANNING
FEB 2019	-	ISSUED FOR INFORMATION
DATE	NO.	REVISION
PROJECT: PROSPECT TELECOMMUNICATION TOWER REPLACEMENT		
TITLE: SERVICES IDENTIFICATION AND RELOCATION		
SCALE:	AS SHOWN	JOB NO.: 18-033
DRAWN BY:	MSK	DRAWING #: SE1.0
DATE:	FEB 2020	

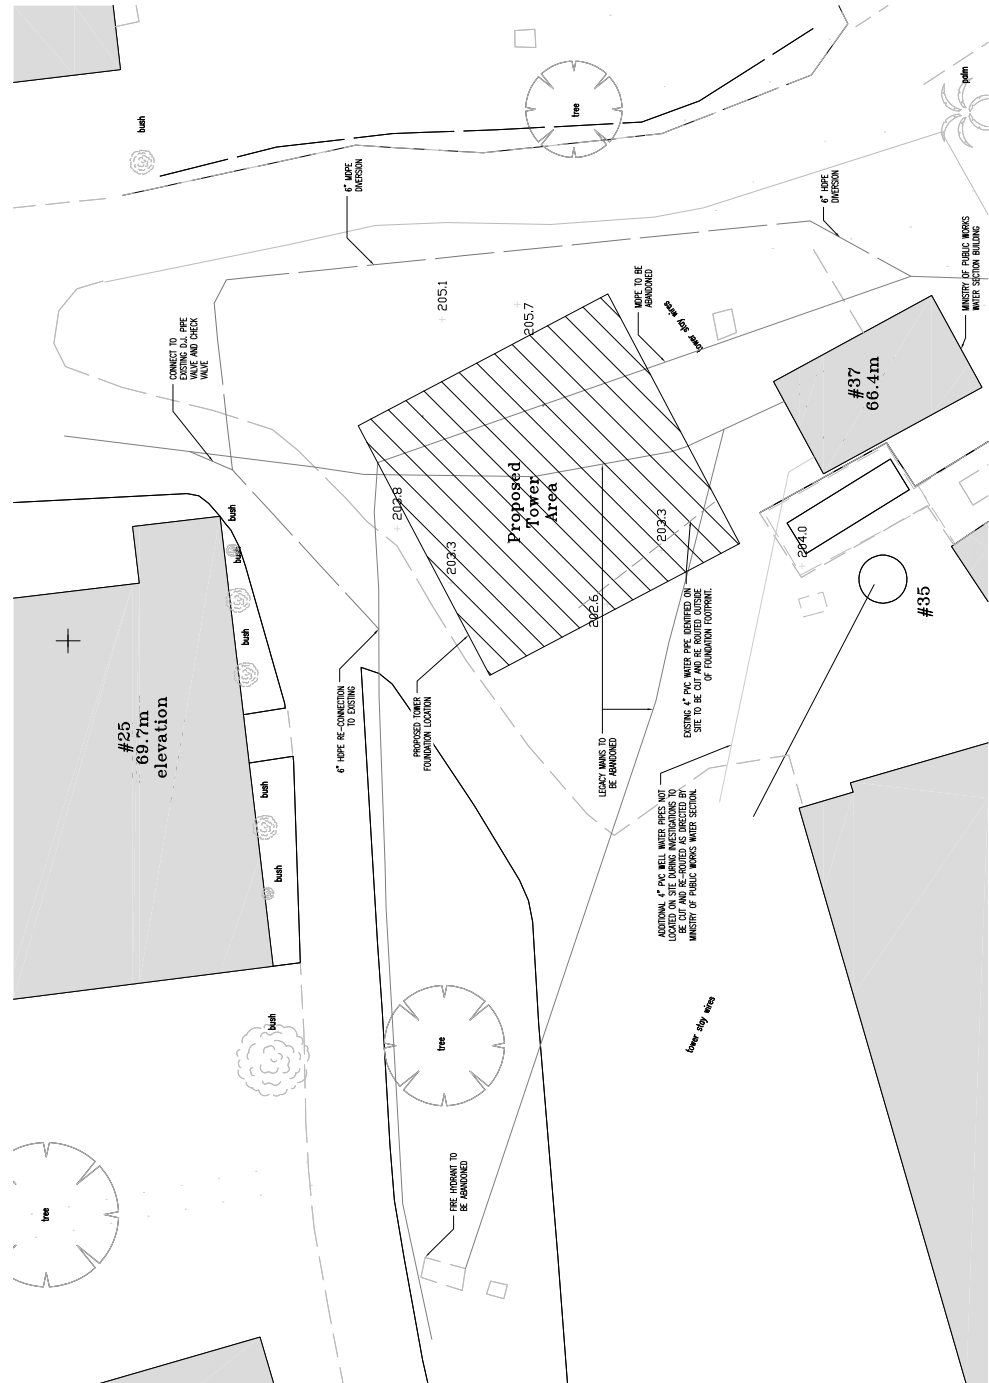

1 SERVICES PLAN
SCALE 1/8" = 1'-0"

DRAWING SCALE SHOWN IS FOR FULL-SIZE SHEETS AND IS NOT TO BE USED FOR SECTION SHEETS. SHEETS ARE FULL SCALE DRAWING UNLESS NOTED OTHERWISE.
 24" X 36" SHEET = 18" X 24" ON 11" X 17" SHEET