

ISSUED FOR: 10/10/16

AMENDMENTS:

NO	REVISION	BY	APP	DATE
1	PLANNING			10/10/16

SCALE: 1/2"=1'0"

**SURVEY**  
PREPARED BY: RS DATE: 10/10/16

**DESIGN**  
PREPARED BY: RS DATE: 10/10/16  
CHECKED BY: RS DATE: 10/10/16

**DRAWING**  
PREPARED BY: RS DATE: 10/10/16  
CHECKED BY: RS DATE: 10/10/16

APPROVED BY: RS DATE: 10/10/16

PROJECT NUMBER:

PROJECT NAME:


**FORT PROSPECT  
CENTRAL AREA  
PUMP STATION**  
Fort Hill Road

**Devonshire**

SHEET TITLE:

**PUMPING STATION  
ELECTRICAL FLOOR PLANS**

SHEET NUMBER: **E5** REVISION: **1**

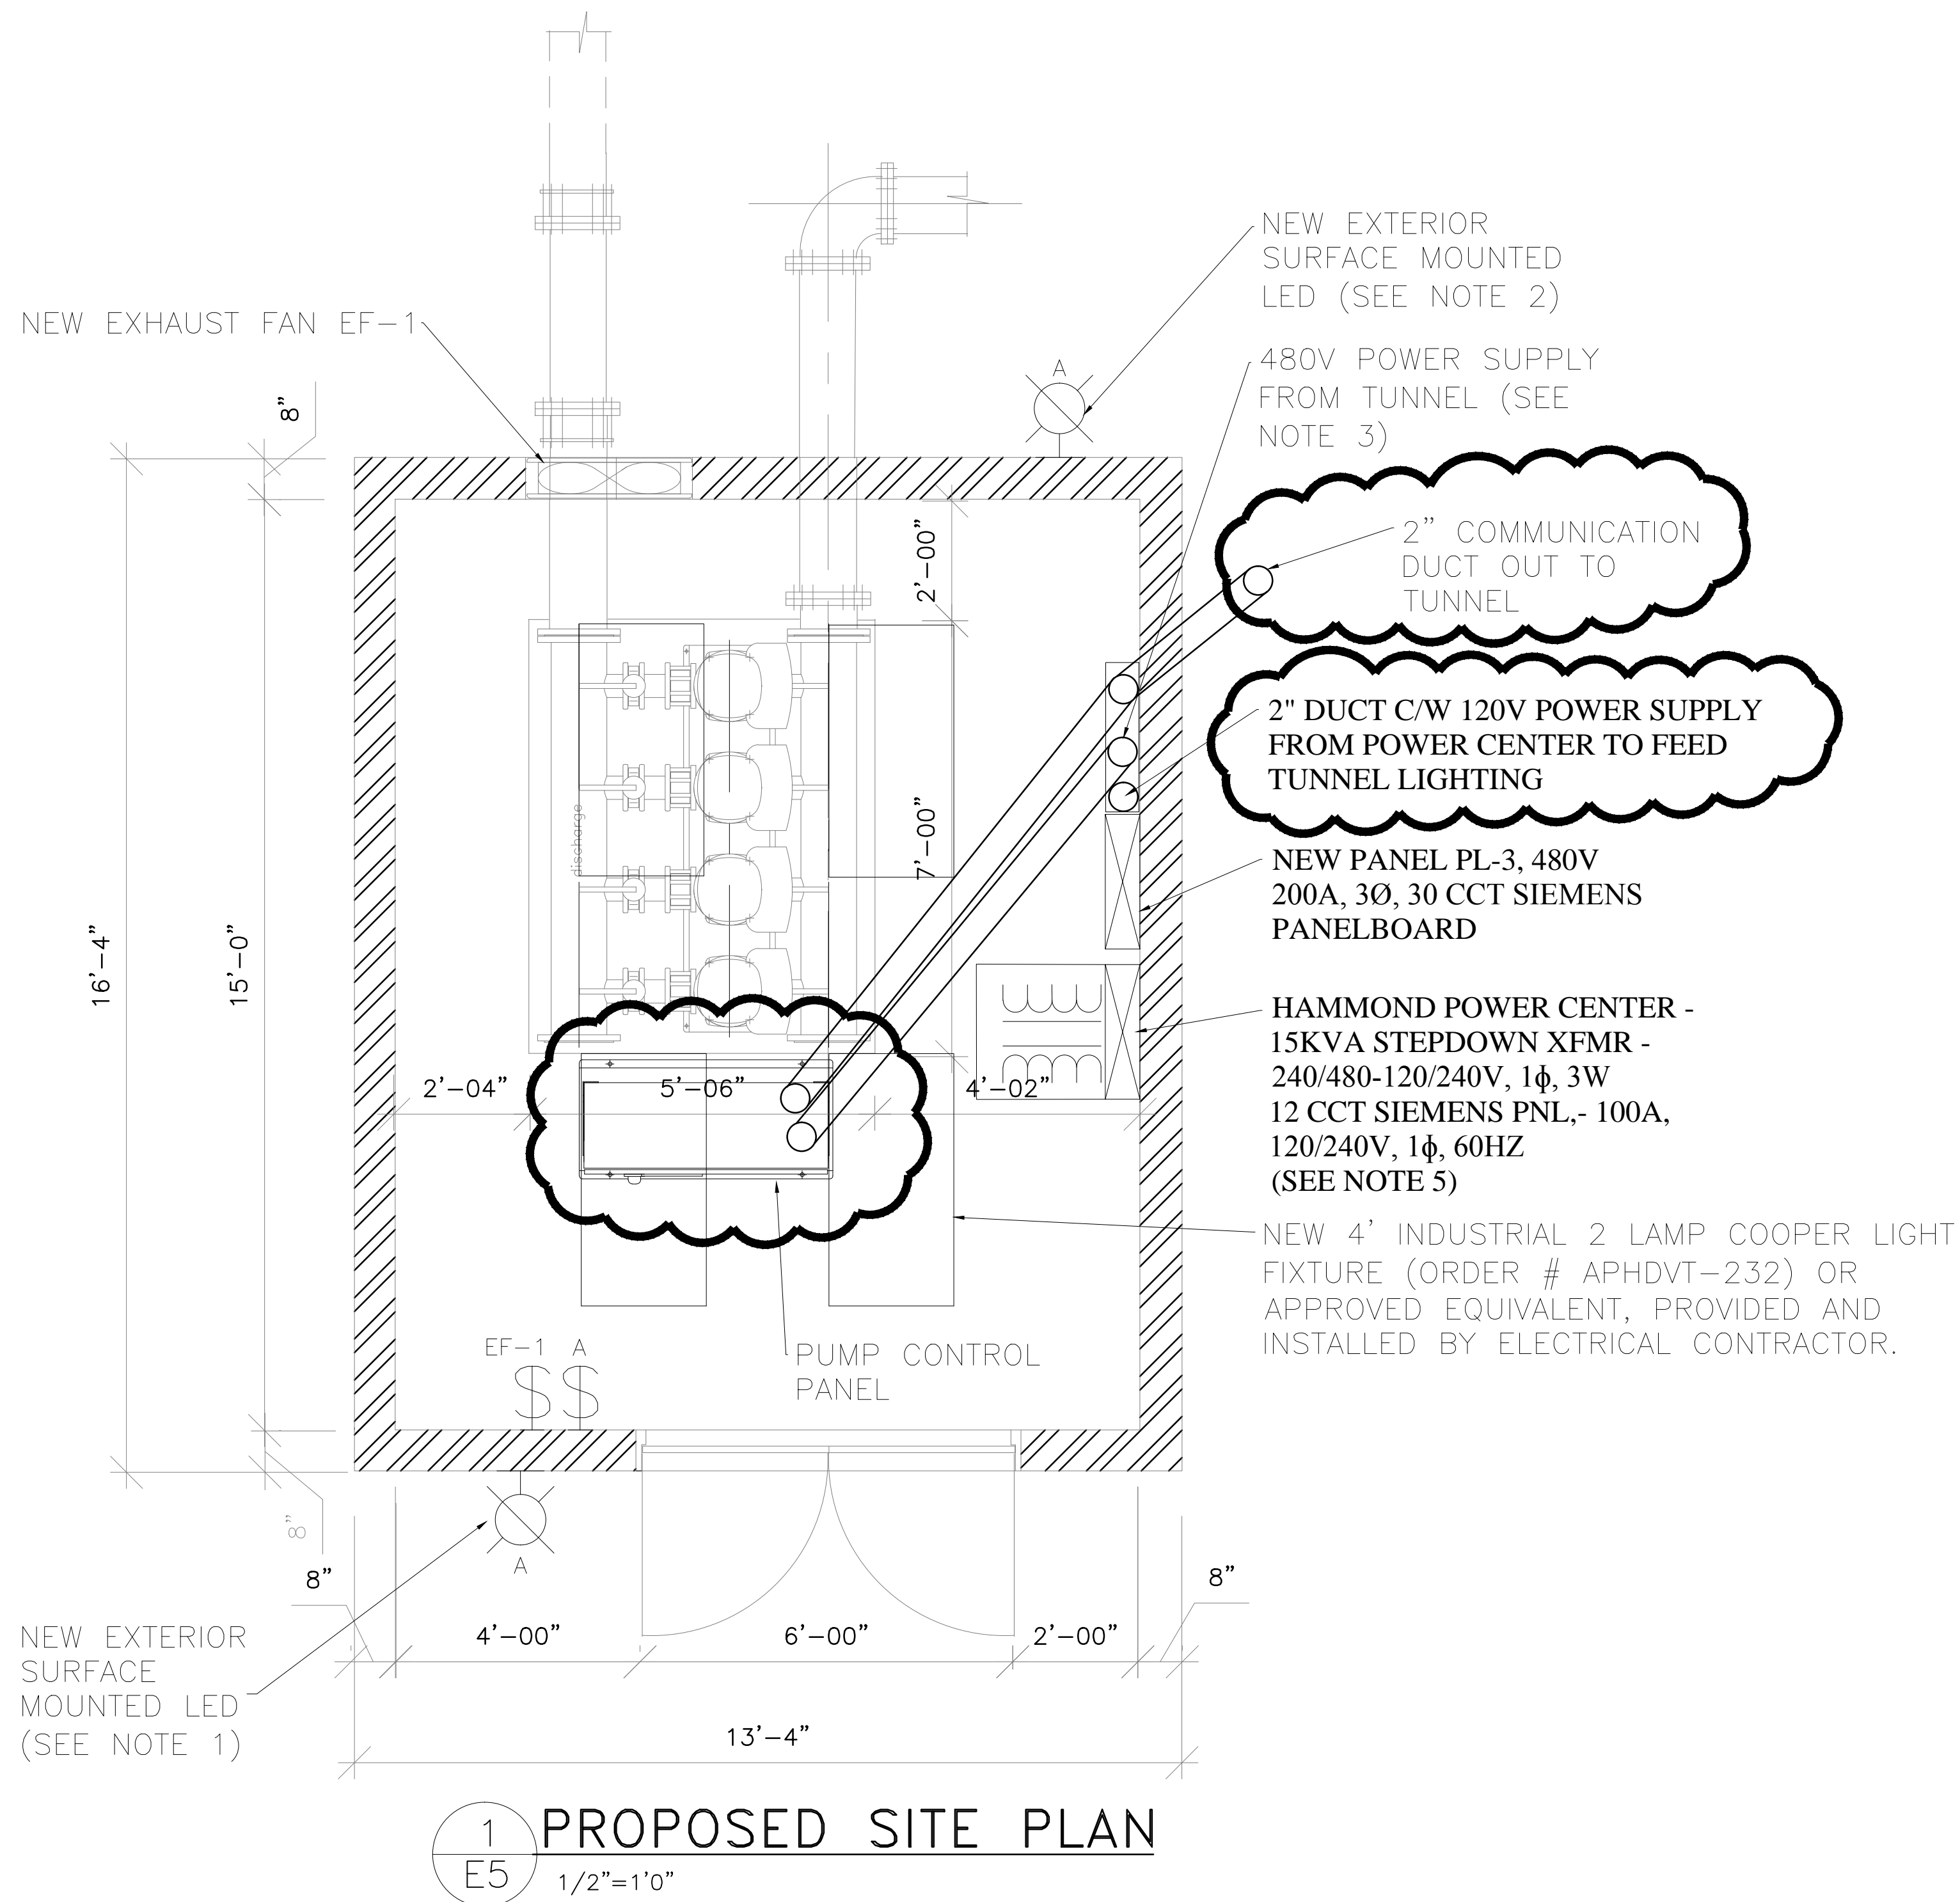

NOTES:

1. THE ENTIRE ELECTRICAL INSTALLATION SHALL CONFORM TO THE BERMUDA BUILDING CODE, NATIONAL ELECTRIC CODE (2008), NFPA 72 (2010), AND NFPA 101 (2012). REFER TO ELECTRICAL SPECIFICATIONS.
2. ELECTRICAL CONTRACTOR SHALL PROVIDE AND INSTALL NEW LITHONIA LED WALL PACK (ORDER # OLV-23) OR APPROVED EQUIVALENT.
3. NEW 2" CONDUIT CHanneled FROM TUNNEL SHALL BE SUPPLIED AND INSTALLED BY ELECTRICAL CONTRACTOR.
4. NEW 2" CONDUIT CHanneled BACK TO TUNNEL SHALL BE SUPPLIED AND INSTALLED BY ELECTRICAL CONTRACTOR.
5. HAMMOND POWER CENTER SHALL BE SUPPLIED BY PUBLIC WORKS AND INSTALLED BY THE ELECTRICAL CONTRACTOR.