




**SITE PLAN**  
N.T.S.

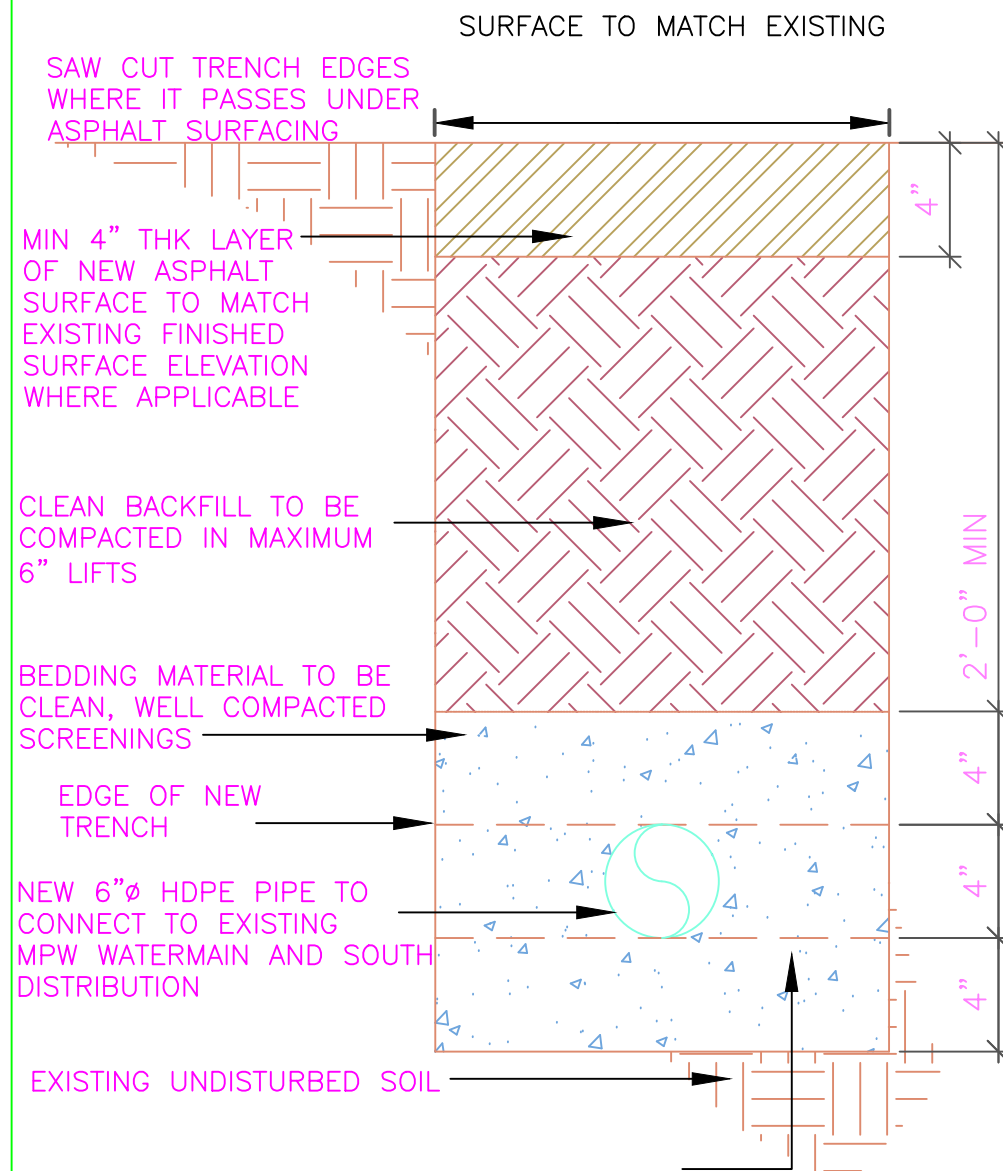

**CROSS-SECTION OF NEW TRENCH**  
N.T.S.

**NOTES**

1. DISTANCE OF NEW 6"Ø HDPE PIPE IS 620'.
2. AT POINT A CONNECT TO EXISTING 6"Ø FLANGED HDPE PIPE LINE CONNECTION.
3. AT POINT B LEAVE SETTLE AND EXCAVATE TRENCH ONLY.
4. AT POINT C CAPP THE END OF THE NEW 6"Ø HDPE PIPE.

ISSUED FOR: TENDER CONSTRUCTION

AMENDMENTS:

NO	REVISION	BY	APP	DATE

SCALE: N.T.S.

SURVEY  
PREPARED BY: DATE:

DESIGN  
PREPARED BY: ABHAYWARD DATE: 21/10/16  
CHECKED BY: DATE:

DRAWING  
PREPARED BY: ABHAYWARD DATE: 17/11/16  
CHECKED BY: KC DATE: 26/1/17

APPROVED BY: DATE:

PROJECT NUMBER:

PROJECT NAME:

**SOUTH DISTRIBUTION  
PIPE REPLACEMENT**

**FORT HILL ROAD  
DEVONSHIRE**

SHEET TITLE:  
**TRENCH LOCATION  
AND SECTION**

SHEET NUMBER:

**W01**

REVISION

1